


IF IN DOUBT - ASK

**KEY**

- (SD) SMOKE DETECTOR
- (W) WATER EXTINGUISHER
- (F) FOAM EXTINGUISHER
- (P) DRY POWDER EXTINGUISHER
- (C2) CO2 EXTINGUISHER
- (C) WET CHEMICAL EXTINGUISHER
- (EL) EMERGENCY LIGHT
- (FB) FIRE BLANKET
- (E3) ILLUMINATED 'EXIT' SIGN WITH DIRECTIONAL ARROW
- [CIG] CIGARETTE VENDING MACHINE
- [AWP] FRUIT MACHINE
- [HEAT] EXTERNAL ELECTRIC HEATER
- [LAMP] EXTERNAL LIGHTING



**FRONT ELEVATION**

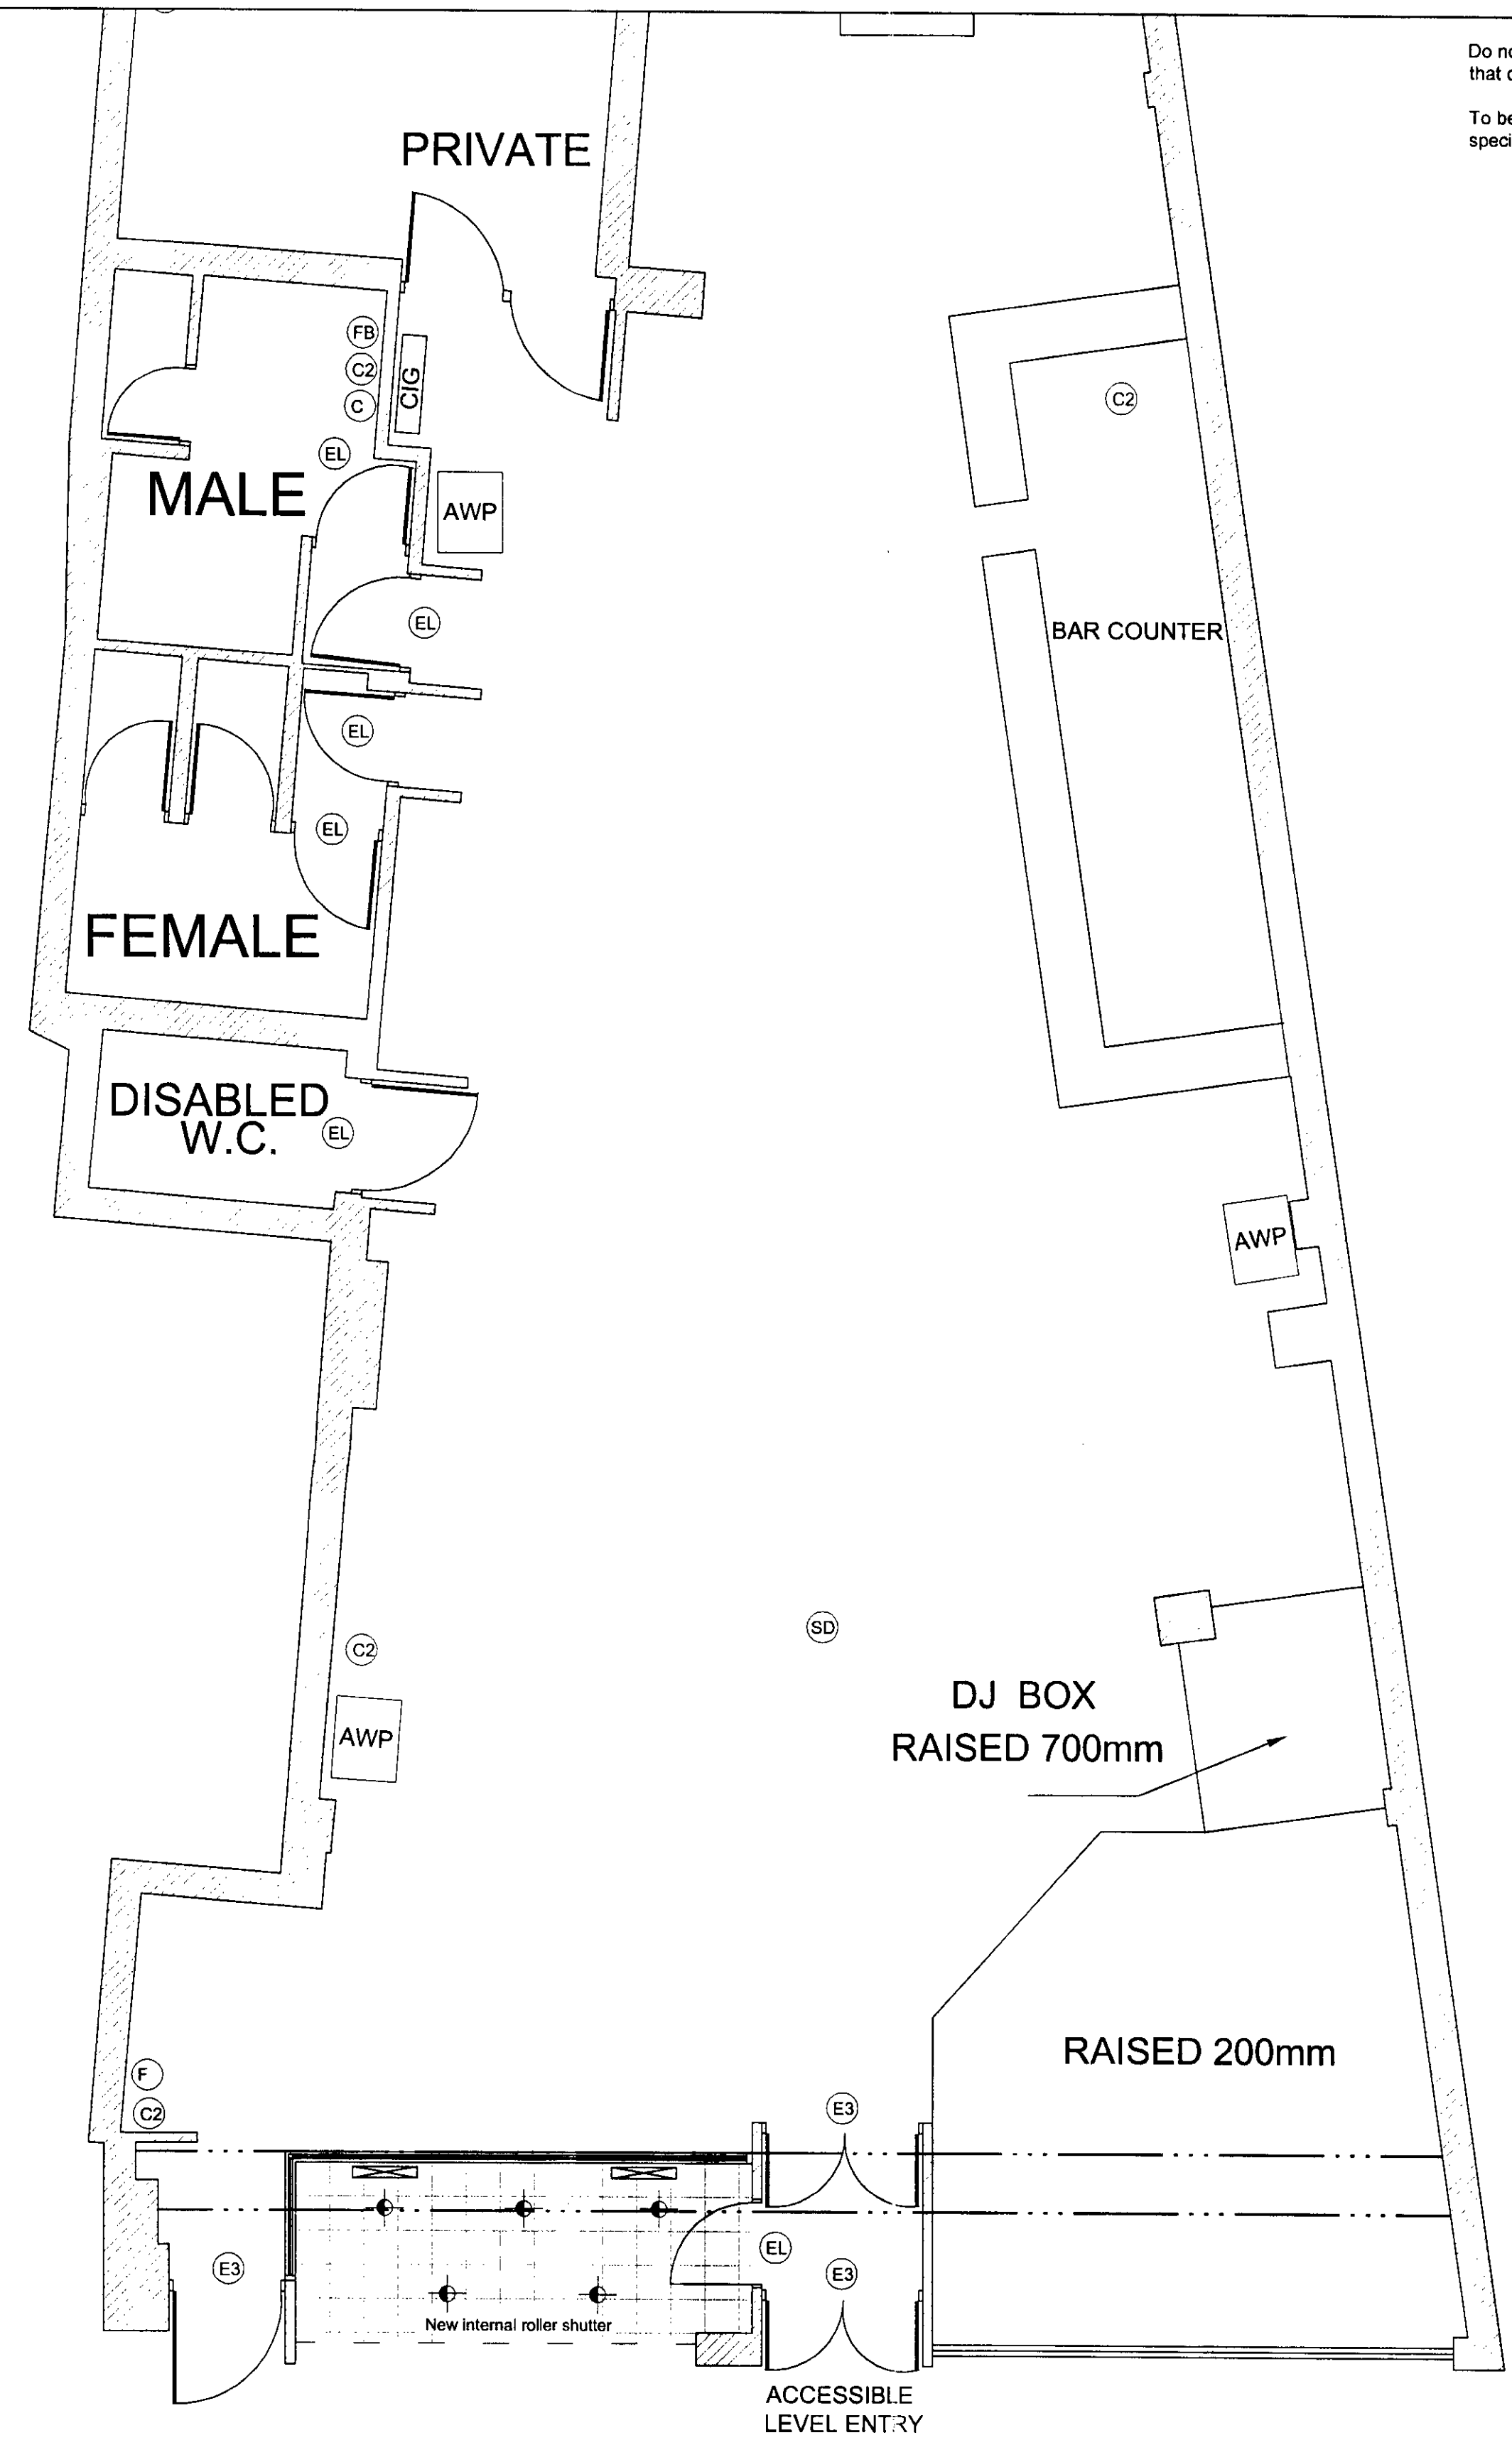

**GROUND FLOOR PLAN**

Do not scale. Use dimensions shown and dimensions that can be calculated.  
To be read in connection with construction notes / specification.

APPLICATION VALID  
Y07/0034/SH  
-5 MAR 2007

RECEIVED  
10 MAR 2007

XXXX	Original Issue	ALE	Dec 2006
revision	details	drawn	date

project Mustangs Rendezvous Street Folkestone		<b>LOFTING CONSULTING</b> CHARTERED BUILDING SURVEYORS 112d High Street, Hythe, Kent, CT21 5LE Tel: 01303 263370 Fax: 01303 263371	
title Proposed Layout & Elevation		drawing number <b>1641/02</b>	
date Dec 2006	scale 1:50 @ A1		